


BILL OF MATERIALS	
CATALOG No.	DESCRIPTION
HUDT4A-NL-3HS-40W-4K-120-PTDR-BK-TX	40 WATT LED COACH STYLE LUMINAIRE (BLACK), POST TOP MOUNTED AS MANUFACTURED BY CYCLONE
MA-250-B-2-BE-30	7.6m OCTAGONAL CONCRETE POLE (BLACK), MADISON SERIES AS MANUFACTURED BY USI

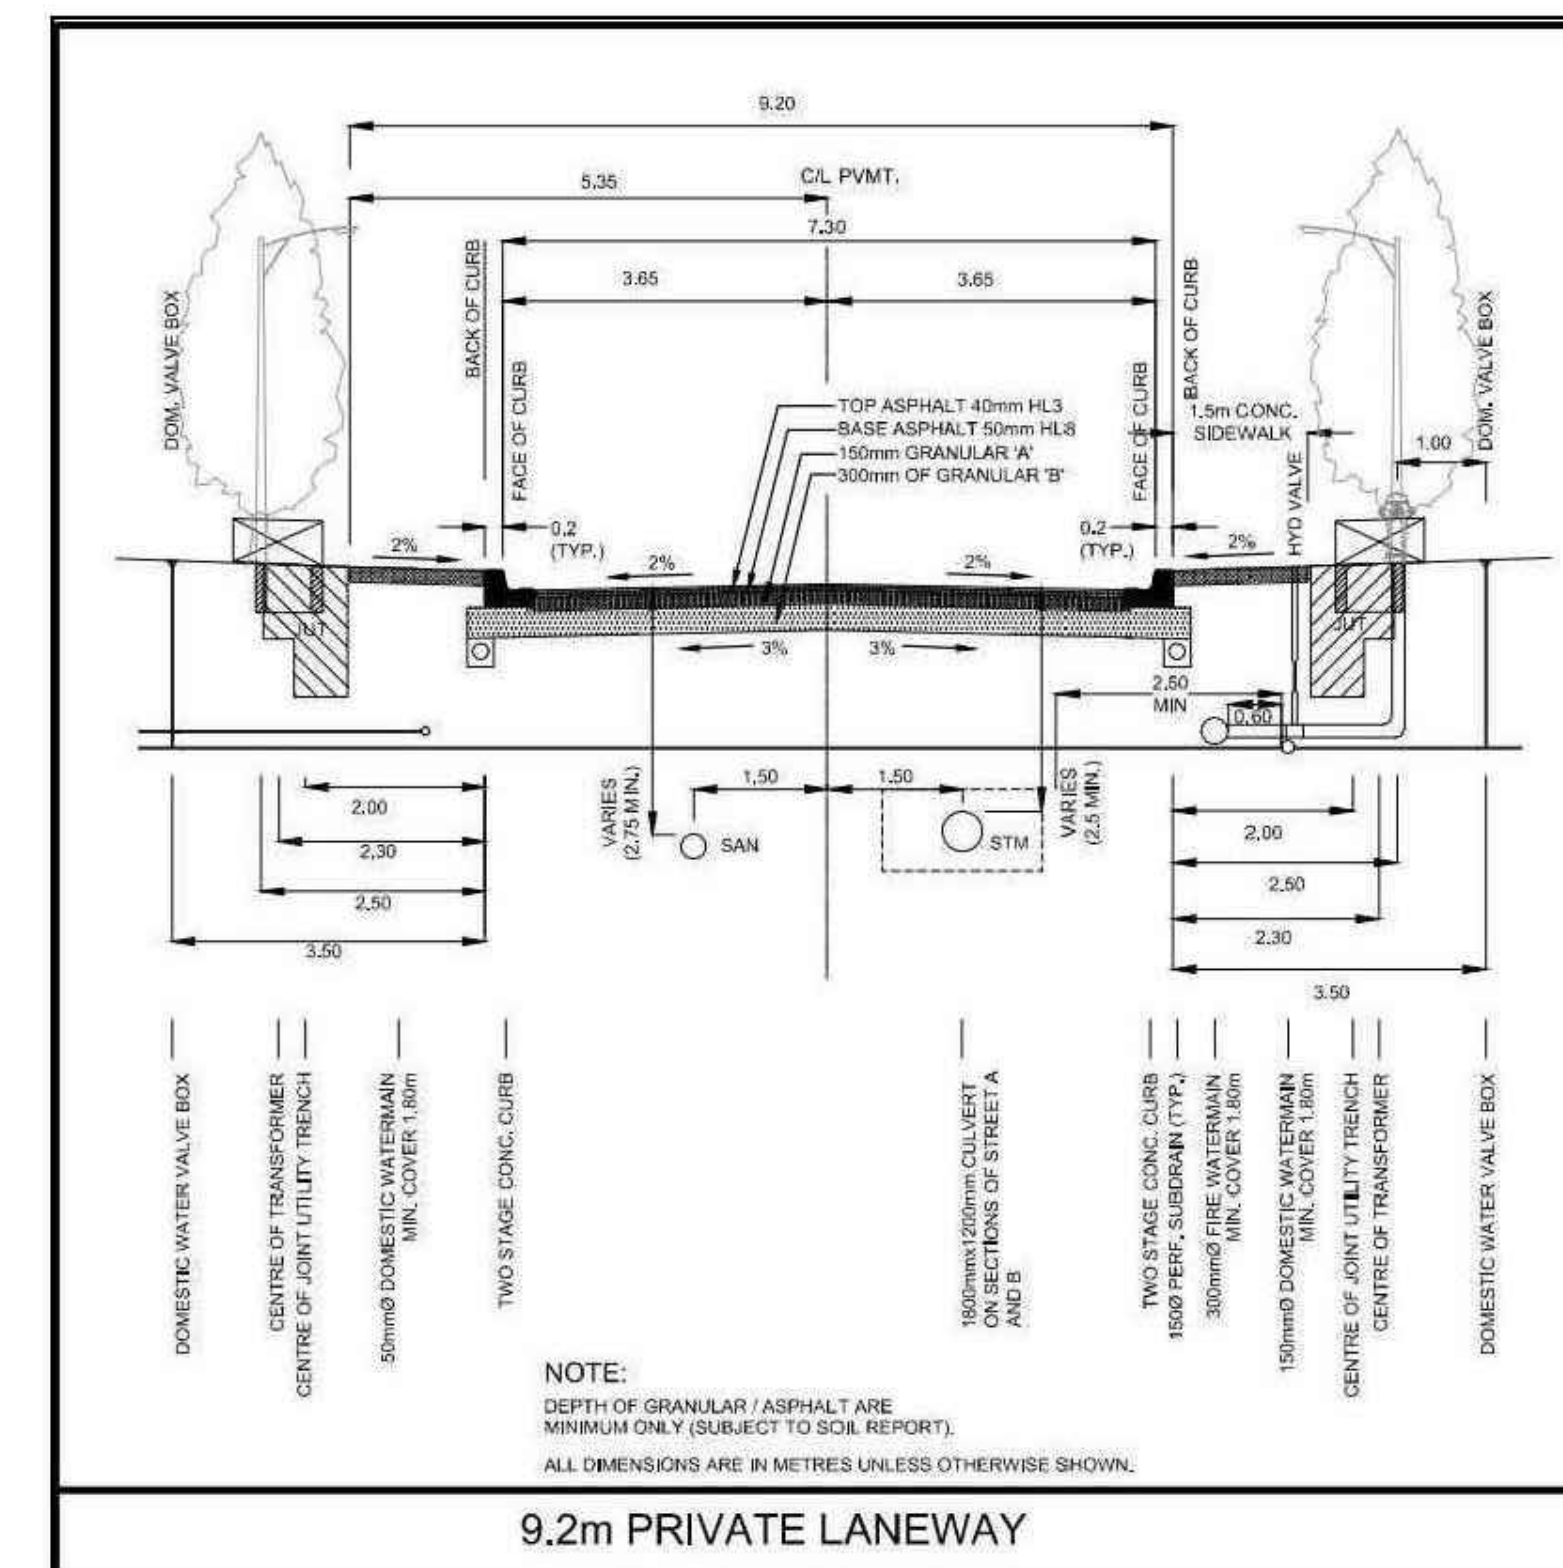

- LEGEND:
- ☒ PROPOSED HYDRO TRANSFORMER
 - PROPOSED DIRECT BURIED 50mm DUCT BANK
 - PROPOSED STREET LIGHT
 - PROPOSED STREET LIGHT CABLE
 - SD DISCONNECT PANEL BY BUILDING ELECTRICIAN
 - ⊕ PROPOSED GROUNDING
 - ⊙ PROPOSED STREET LIGHT METER
 - PROPOSED FIRE HYDRANT

- GENERAL NOTES:
- THIS PLAN SHALL BE READ IN CONJUNCTION WITH THE COMPOSITE UTILITY PLAN AND THE TOWNSHIP OF UXBRIDGE STANDARDS SHALL GOVERN OVER THIS DRAWING.
 - ALL WORK SHALL BE CARRIED OUT IN COMPLIANCE WITH THE ONTARIO OCCUPATIONAL HEALTH AND SAFETY ACT AND REGULATIONS FOR CONSTRUCTION PROJECTS.
 - ALL WORK AND MATERIALS TO CONFORM WITH CURRENT MINISTRY OF THE ENVIRONMENT & ENERGY OF ONTARIO, TOWNSHIP OF UXBRIDGE AND ONTARIO PROVINCIAL STANDARDS AND SPECIFICATIONS. LOCAL UTILITY STANDARDS AND MINISTRY OF TRANSPORTATION STANDARDS WILL APPLY WHERE REQUIRED.
 - THE CONTRACTOR IS ADVISED THAT WORKS BY OTHERS MAY BE ONGOING DURING THE PERIOD OF THIS CONTRACT. THE CONTRACTOR SHALL COORDINATE CONSTRUCTION ACTIVITIES AND COORDINATION WITH ALL OTHER CONTRACTORS AND PREVENT CONSTRUCTION CONFLICTS.
 - THE INFORMATION SHOWN FOR EXISTING UTILITIES WAS PROVIDED BY OTHERS. THE CONTRACTOR IS RESPONSIBLE FOR LOCATING AND PROTECTING ALL UTILITIES DURING CONSTRUCTION.
- STREET LIGHTING NOTES
- STREET LIGHT CABLE (IN 50mm DUCT) TO BE INSTALLED IN JOINT-USE TRENCH, WHERE APPLICABLE.
 - STREET LIGHTS SHALL BE A MINIMUM OF 1.5m FROM DRIVEWAYS AND 1.0m FROM CATCH BASIN LEADS.
 - ALL DIRECT BURIED ROAD CROSSINGS TO EXTEND 0.5m BEYOND CURB.
 - THE LIGHTING FOR THE 2 INTERSECTIONS OFF BROCK STREET EAST ARE NOT PART OF THIS DESIGN.
 - THE SPEED LIMIT IN THIS SUBDIVISION IS 50 km/h - NOT POSTED.

NO.	DESCRIPTION	DATE	BY
1	SUBMITTED FOR APPROVAL	9/14/2021	DAP

UB UTILITY BOX DESIGNS
 Residential + Commercial Development
 25 Ritchie Ave, Unit 102 Toronto, Ont M6G 3R1
 416 666 7500 dpoirier@utilitybox.ca

CLIENT

The Township of
UXBRIDGE
Trail Capital of Canada

PROJECT NAME
**BROCK STREET SOUTH
 UXBRIDGE, ONTARIO**

DRAWING NAME
STREET LIGHT DESIGN

DATE: SEPT 2021
 SCALE: 1:500
 PROJ. No: UBD-0459
 DWG. No: SL-1

